


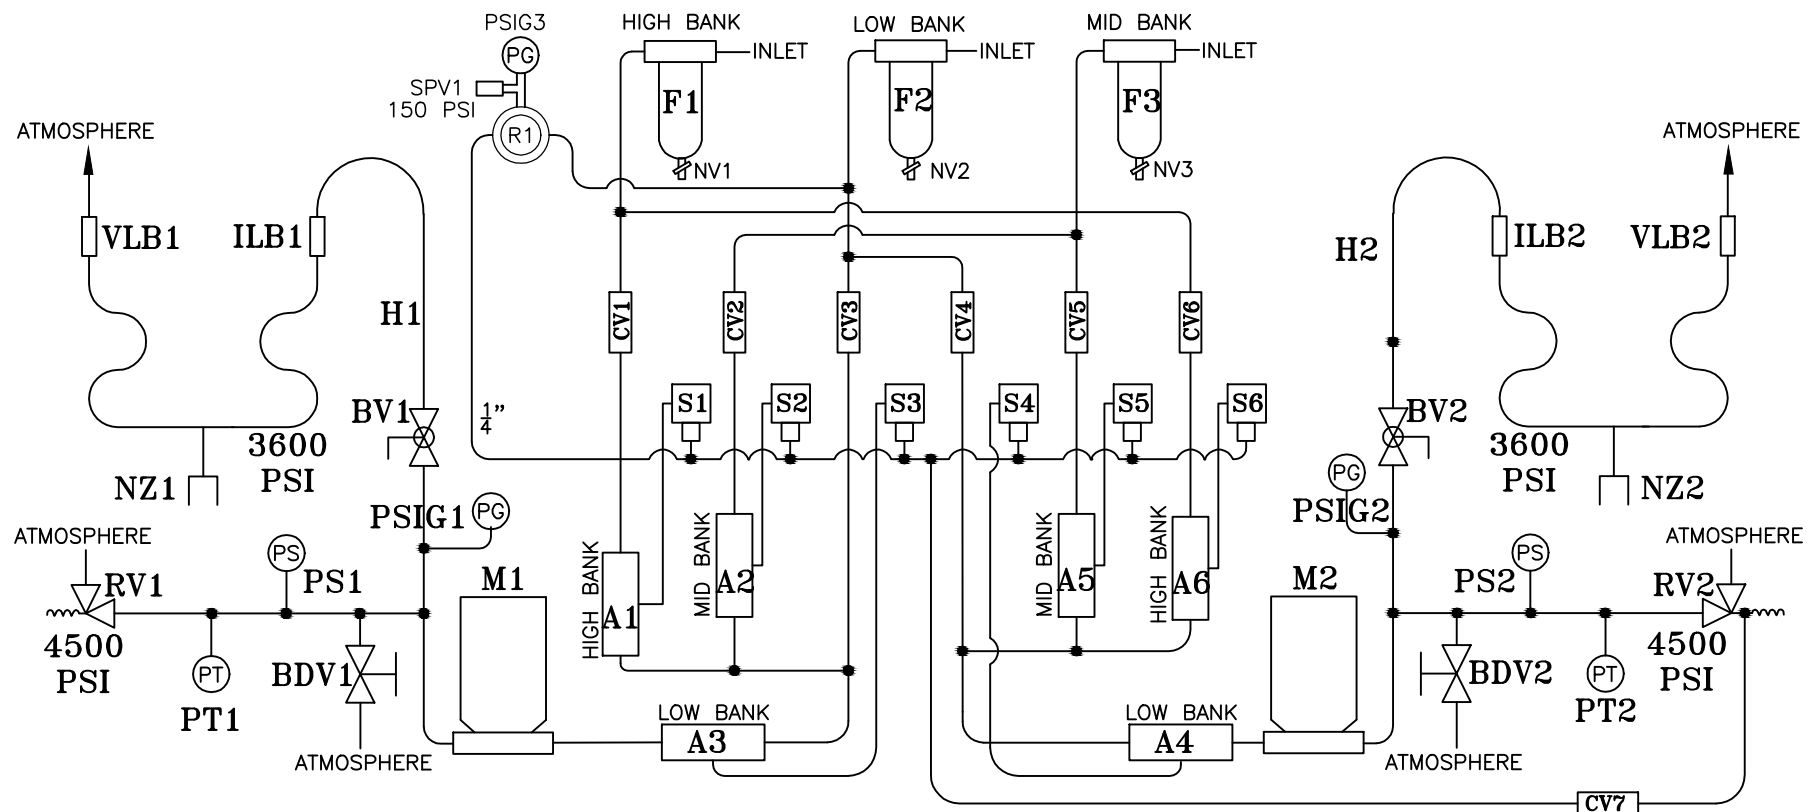

A1-6.....BI-TORQ ACTUATOR WITH 1/2" OASIS BALL VALVE
 BDV1,2.....BLEED VALVE, PARKER
 BV1, BV1.....PARKER 1/2" BALL VALVE, 62 SERIES
 CV1,2,3,4,5,6..OASIS CHECK VALVE, SERIES 200
 CV7.....OASIS CHECK VALVE, SERIES 100
 F1,F2,F3.....FILTER, TGT A8519C-N-3MA-S6
 H1.....HOSE, PARKER PARFLEX 3/8"
 H2.....HOSE, PARKER PARFLEX 3/8"
 ILB1,2.....INLINE BREAKAWAY, TGT 6ILB
 M1,2.....METER, MICRO MOTION SENSOR MM-CNG50S290NCAAEZZZ
 MICRO MOTION TRANSMITTER MM-2700I13ABEZZZ
 NV1,2,3.....NEEDLE VALVE, NOSHOK
 NZ1.....OPW CT5000
 NZ2.....WEH TK17
 PSIG1,2.....TGT 2.5" GAUGE 5000PSI
 PSIG3.....NOSHOK, SERIES 900 0-200PSI
 PS1,PS2.....NASON PRESSURE SENSOR, CD-1C-45000R/WL293
 PT1,PT2.....ASHCROFT PRESSURE TRANSMITTER, G27M02RMG35000#G
 R1.....BELGAS REGULATOR, MODEL P39, 0-225
 RV1,RV2.....MERCER RELIEF VALVE, 14-22B7112JX1, 4500lb
 VLB1,2.....VENT LINE BREAKAWAY
 S1-6.....ASCO RED HAT SOLENOID VALVE
 SPV1.....KINGSTON LOW PROFILE SAFETY PRESSURE VALVE KSV10, 150PSI



TULSA GAS TECHNOLOGIES, INC.
 4809 South 101st East Avenue
 Tulsa, OK 74146
 (918) 665-2641 FAX: (918) 665-2657

MODEL:	DRAWN BY: TC	DATE
SEQUENCE -	CHECKED BY: -	12-12-19
PROGRAM: -	APPROVED BY: -	9-6-22
SERIAL NO.:	PART: -	
WORK ORDER: -	DWG. NO. T7203-8CNG50W P&ID	