


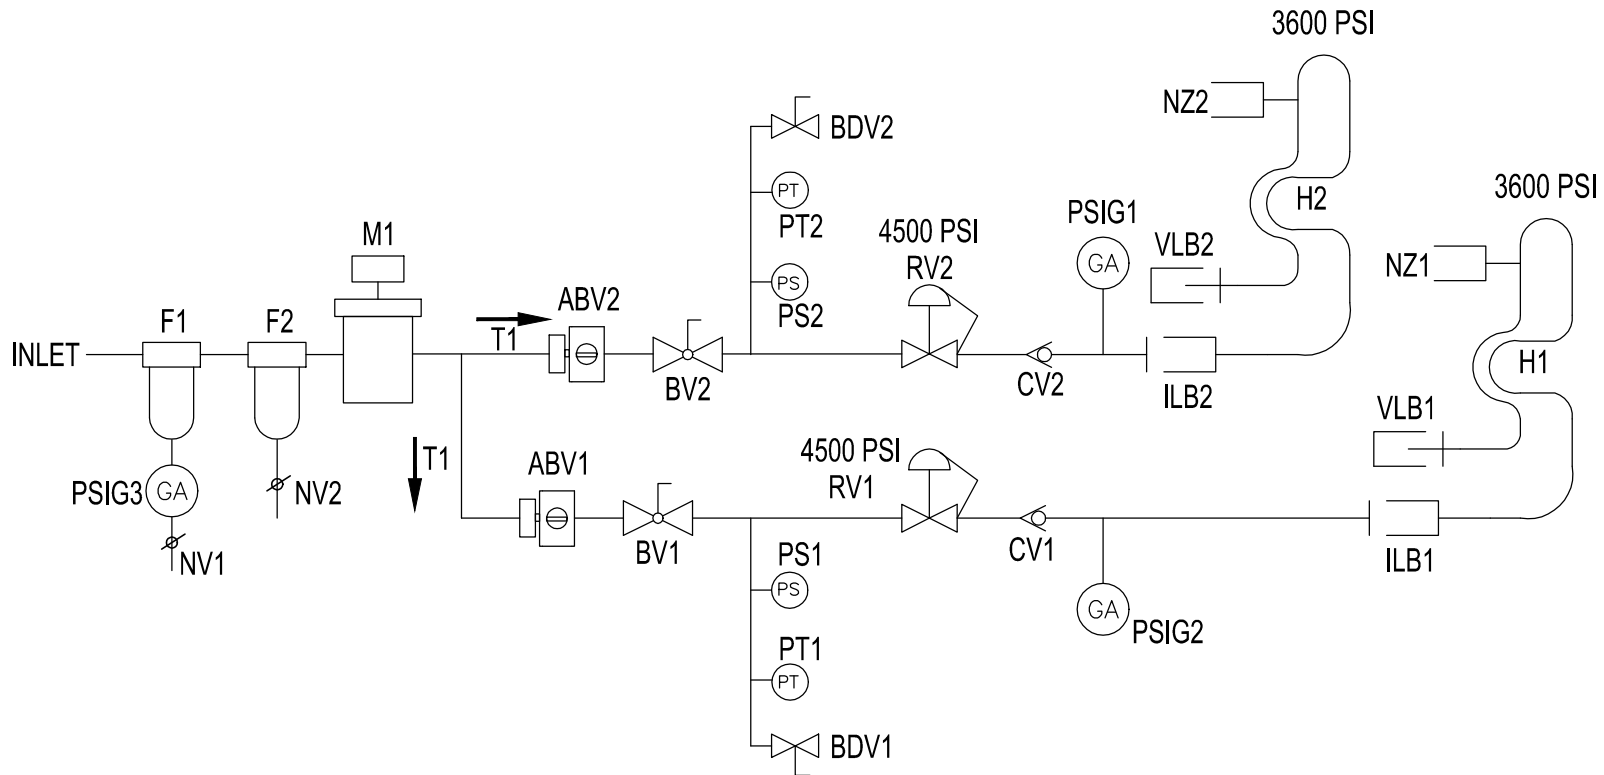

ABV1.....OASIS BALL VALVE BV704 SERIES 52 WITH BI-TORQ ACTUATOR
 ABV2.....OASIS BALL VALVE BV706 SERIES 63 WITH BI-TORQ ACTUATOR
 BDV1,2.....PARKER BLEED VALVE, 4M-BV4-SS
 BV1.....OASIS BALL VALVE BV704
 BV2.....OASIS BALL VALVE BV706
 CV1.....OASIS CHECK VALVE, CV102-3-NBSO
 CV2.....OASIS CHECK VALVE, CV203-4-NDSN
 ILB1,2.....INLINE BREAKAWAY, OPW
 M1.....MICRO MOTION CNG50 METER, MM-290NCAAEZZZ SENSOR,
 MM270/13ABA3ZZZ - TRANSMITTER
 NZ1.....CT1000
 NZ2.....CT5000S
 NV1,2.....NOSHOK NEEDLE VALVE
 PSIG1,2,3.....2.5" GAUGE 5000PSI, TGT GAUGE
 PS1,2.....NASON PRESSURE SWITCH, CD-1C-4500-WL293
 PT1,2.....PRESSURE TRANSMITTER, MURPHY TRANSDUCER PXT-K-6000
 RV1,2.....MERCER RELIEF VALVE, 14-22B7112JX1
 VLB1,2.....VENT LINE BREAKAWAY, TGT
 F1.....FILTER, PARKER J6NH-10CWC23-130B
 F2.....FILTER, PARKER J6NX-4C2C23-130B
 T1.....3/4" .109 WALL
 H1.....1/2" FILL, 1/4" VENT
 H2.....3/4" FILL 3/8" VENT PARKER HOSE



TULSA GAS TECHNOLOGIES, INC.
 4809 South 101st East Avenue
 Tulsa, OK 74146
 (918) 665-2641 FAX: (918) 665-2657

MODEL: T7214-12CNG50	DRAWN BY: TC	DATE
SEQUENCE -	CHECKED BY: -	07/22/25
PROGRAM: -	APPROVED BY: -	
SERIAL NO.: 16121148	PART: -	
WORK ORDER: -	DWG. NO. T7214-12-12-8CNG50W P&ID	