


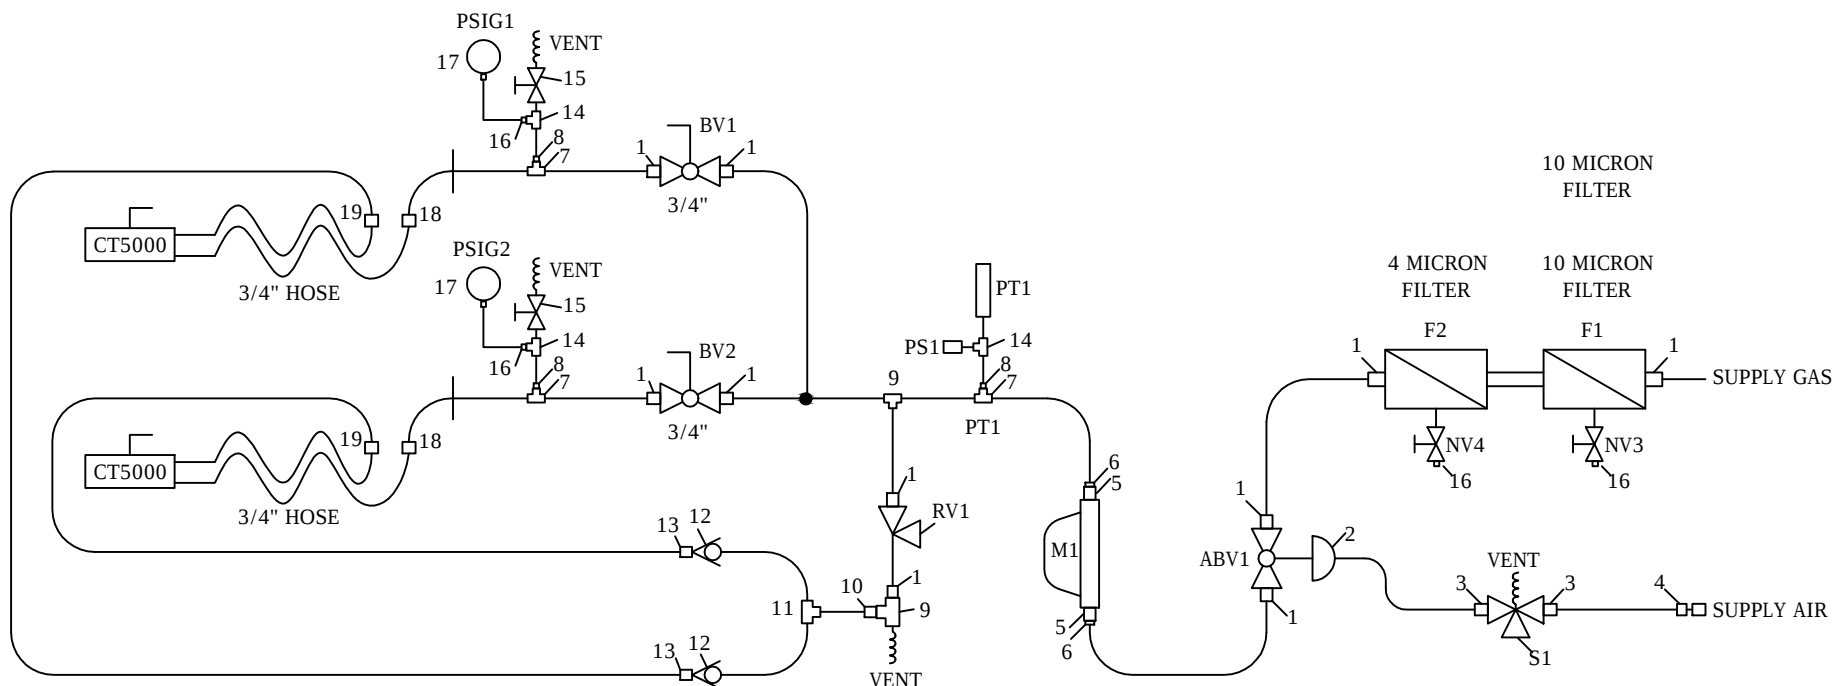

Description	Part Number
1. 3/4" NPT-3/4"	SS-1210-1-12
2. 1/8"NPT-1/4" COMPRESSION 90°	SS-400-2-2
3. 1/4"NPT-1/4" COMPRESSION 90°	SS-400-2-4
4. BULKHEAD NPT FEMALE CONN.	SS-400-71-4
5. 1" ISO/BSP	SS-1610-1-16RS
6. 1" TUBE 3/4" COMPRESS. REDUCER	SS-1210-R-16
7. 3/4" BRANCH TEE (TTF)	SS-1210-3TTF
8. 3/4" MNPT X FNPT	
9. 3/4" UNION TEE	SS-1210-3
10. REDUCER 1/2" TUBE TO 3/4"	SS-810-R-12
11. UNION TEE 1/2"	SS-810-3
12. TGT COMPRESSION CHECK VALVE	CV-8-5000
13. REDUCER 3/8" TUBE TO 1/2"	SS-600-R-8
14. 1/4" STREET TEE (MFF)	SS-4-ST
15. 1/4" NPT NO SHOK BLEED VALVE	152-MFC
16. 1/4" NPT-TUBE	SS-400-1-4
17. 1/4" FEM NPT CONNECTOR	SS-400-7-4
18. 3/4" AN BULKHEAD FITTING	SS-1210-61-12AN
19. 3/8" AN BULKHEAD FITTING	SS-600-6-6AN

Reference	Part Description
ABV1.....	OASIS BALL VALVE BV706-4N6LDDN WITH BI-TORQ ACTUATOR PN75SR
BV1,2.....	OASIS BALL VALVE BV706-4N6LDDN
F1.....	FILTER, PARKER J6NH-10CWC23-130B
F2.....	FILTER, PARKER J6NX-4C2C23-130B
M1.....	1" ENDRESS HAUSER METER DN25 SENSOR, CNGmass - TRANSMITTER
NZ1,2.....	CT5000S
NV1-4.....	NOSHOK NEEDLE VALVE
PS1.....	NASON CD-1C-4500/WL293
PSIG1,2.....	WIKI GAUGE 0-6000PSI
PT1.....	PXT-K6000, 0-6000PSI
RV1.....	MERCER RELIEF VALVE, 14-22B7112JX1
S1.....	RED HAT 120 VAC SOLENOID VALVE (AIR ACTUATED)



TULSA GAS TECHNOLOGIES, INC.
 4809 South 101st East Avenue
 Tulsa, OK 74146
 (918) 665-2641 FAX: (918) 665-2657

MODEL:	DRAWN BY: MB	DATE:
SEQUENCE -	CHECKED BY: -	07-06-24
PROGRAM: -	APPROVED BY: -	
SERIAL NO.: -	PART: -	
WORK ORDER: -	DWG. NO. T7214-12-12CNG50 P&ID	