


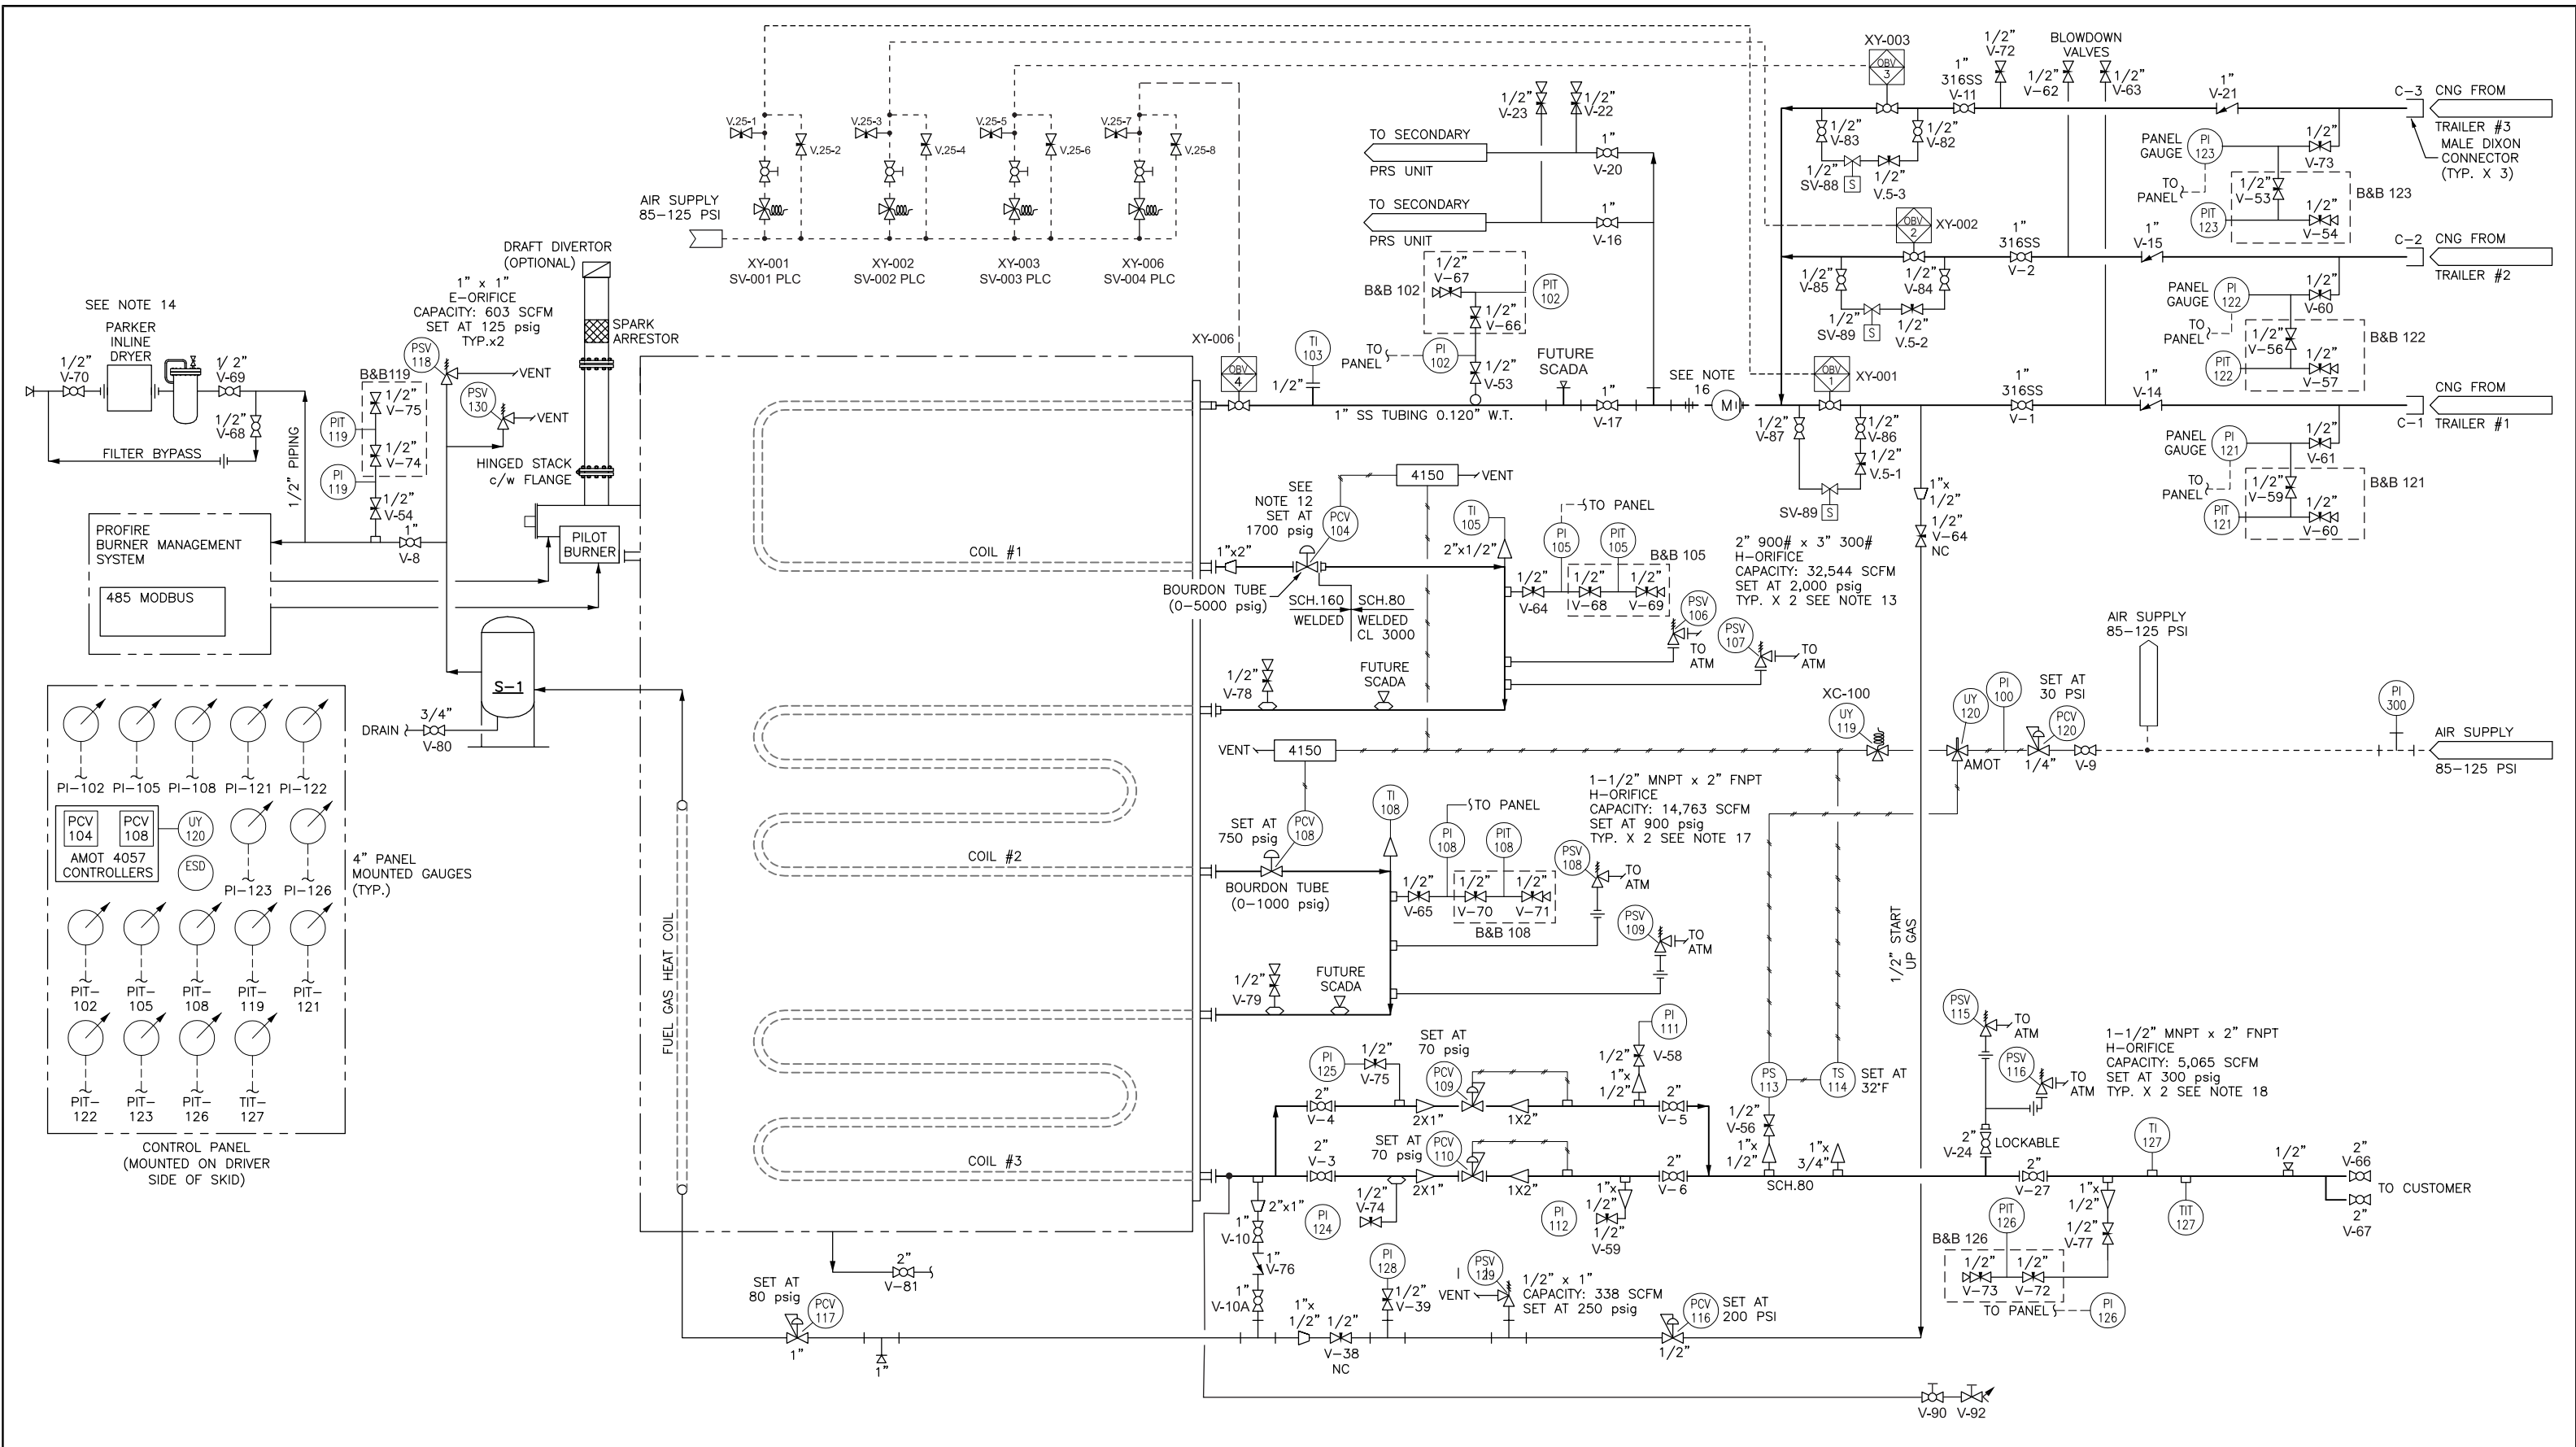

REV	REVISIONS	DATE (yyyy-mm-dd)	BY	CHK'D	PROJ.							TULSA GAS 918-665-2641TECHNOLOGIES, INC.						
L	RE-ISSUED AS BUILT	2024-08-06	WJH	DF	22-166					DRAWN BY:		DATE:		TITLE: LIBERTY POWER INNOVATIONS / TGT PRS UNIT 1200-A JULY 2023 PIPING AND INSTRUMENTATION DIAGRAM SHEET 1				
K	RE-ISSUED AS BUILT	2024-08-03	WJH	DF	22-166					WJH		2023-08-17						
J	AS BUILT	2024-04-23	WJH	GH	22-166					CHECKED BY:		DATE:						
I	RE-ISSUED FOR CONSTRUCTION	2024-04-03	WJH	GH	22-166					GH		2023-08-17						
H	RE-ISSUED FOR CONSTRUCTION	2024-02-06	WJH	GH	22-166													
G	ISSUED FOR CONSTRUCTION	2024-02-01	WJH	GH	22-166					APPROVED BY:		DATE:				DWG. NO.: TGT/LIB-1200A-PID-02		L